




NOTES

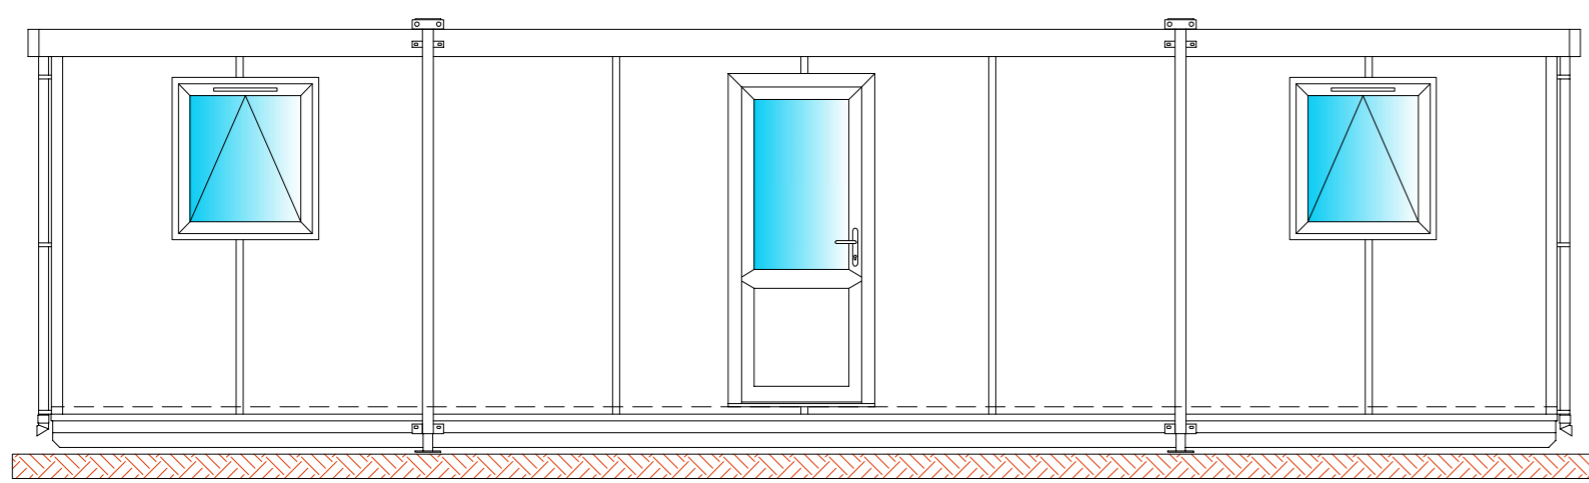

FRONT ELEVATION

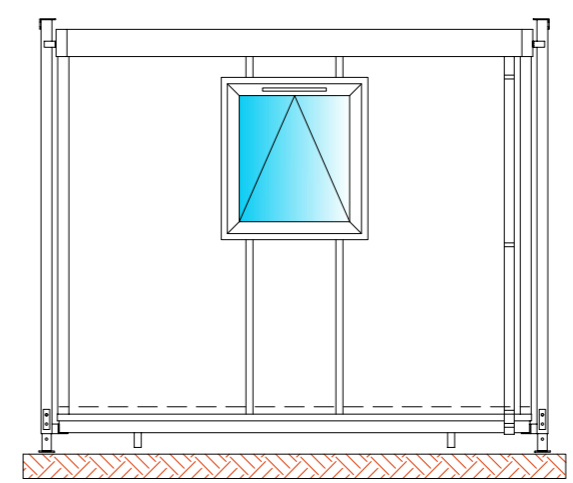

SIDE ELEVATION

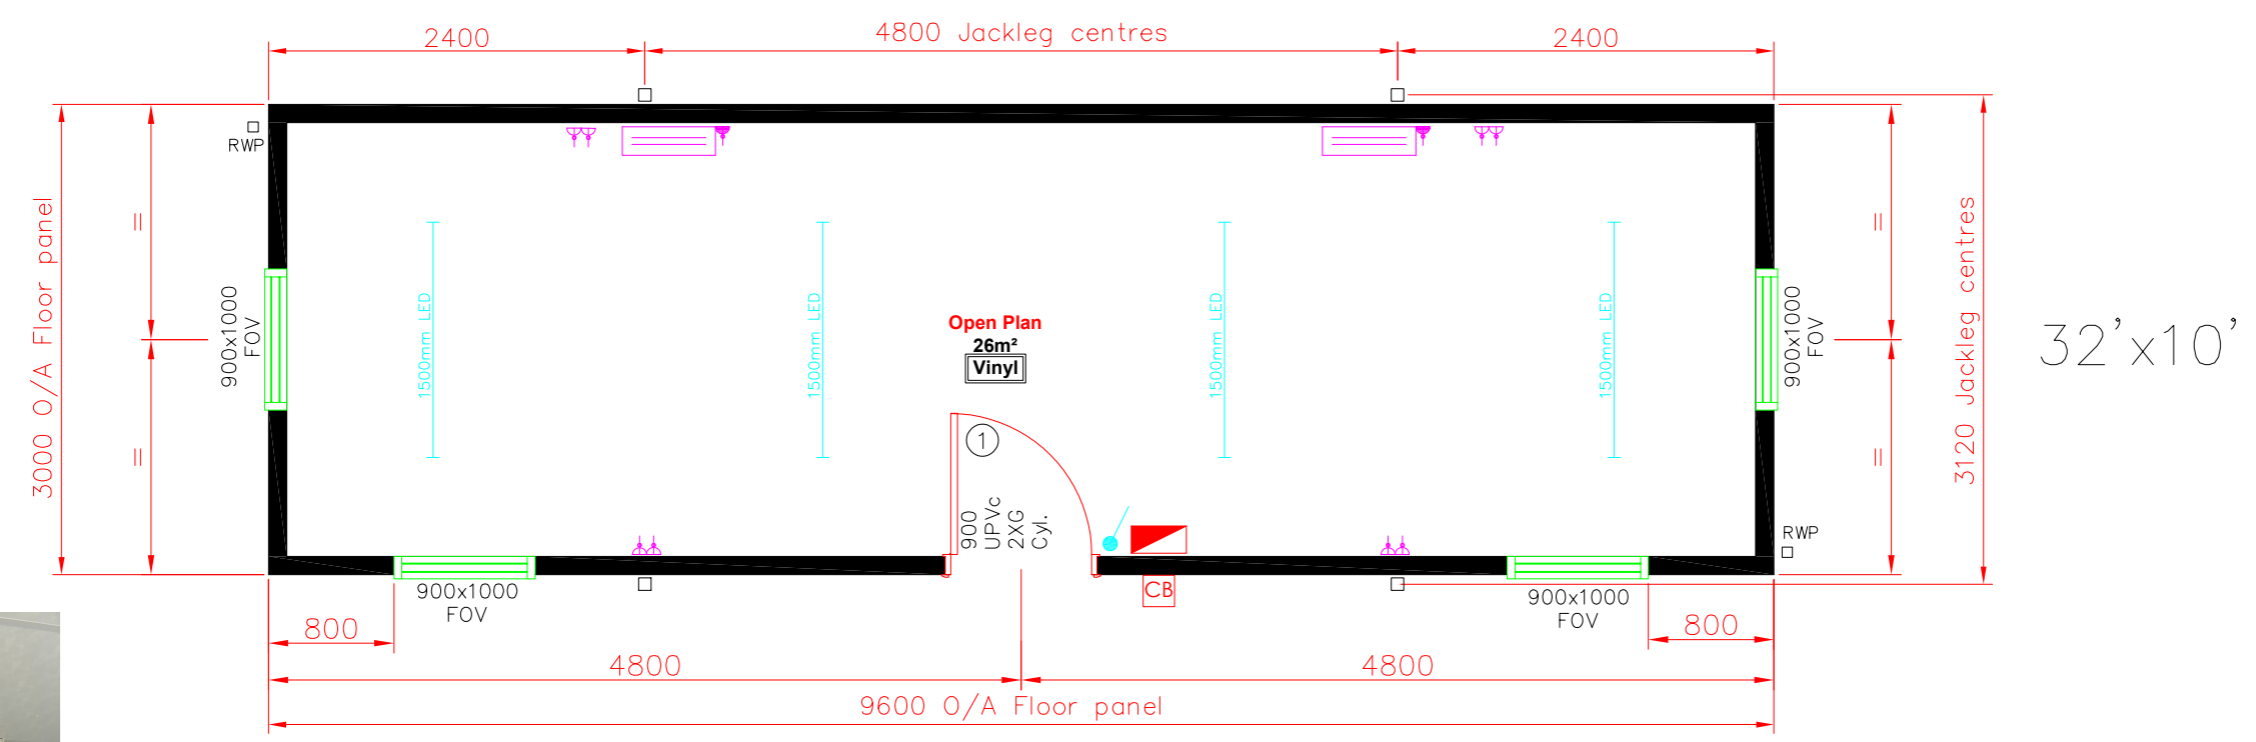

32' x 10'



By	Date	Rev

Quote Ref:

Project

Title  
Plan Layout  
32' x 10'





 
Drawn: MJC Date 17/02/2022

Scale: 1:50 Drawing Size A3



Drawing number JL3210-01A Issue

**Key:**

-  Mains distribution Board
-  Double switched socket outlet low level. 500mm to ct unless stated otherwise
-  Wall switch
-  1500mm LED Light fittings
-  2kW panel heaters